


FIRST FLOOR

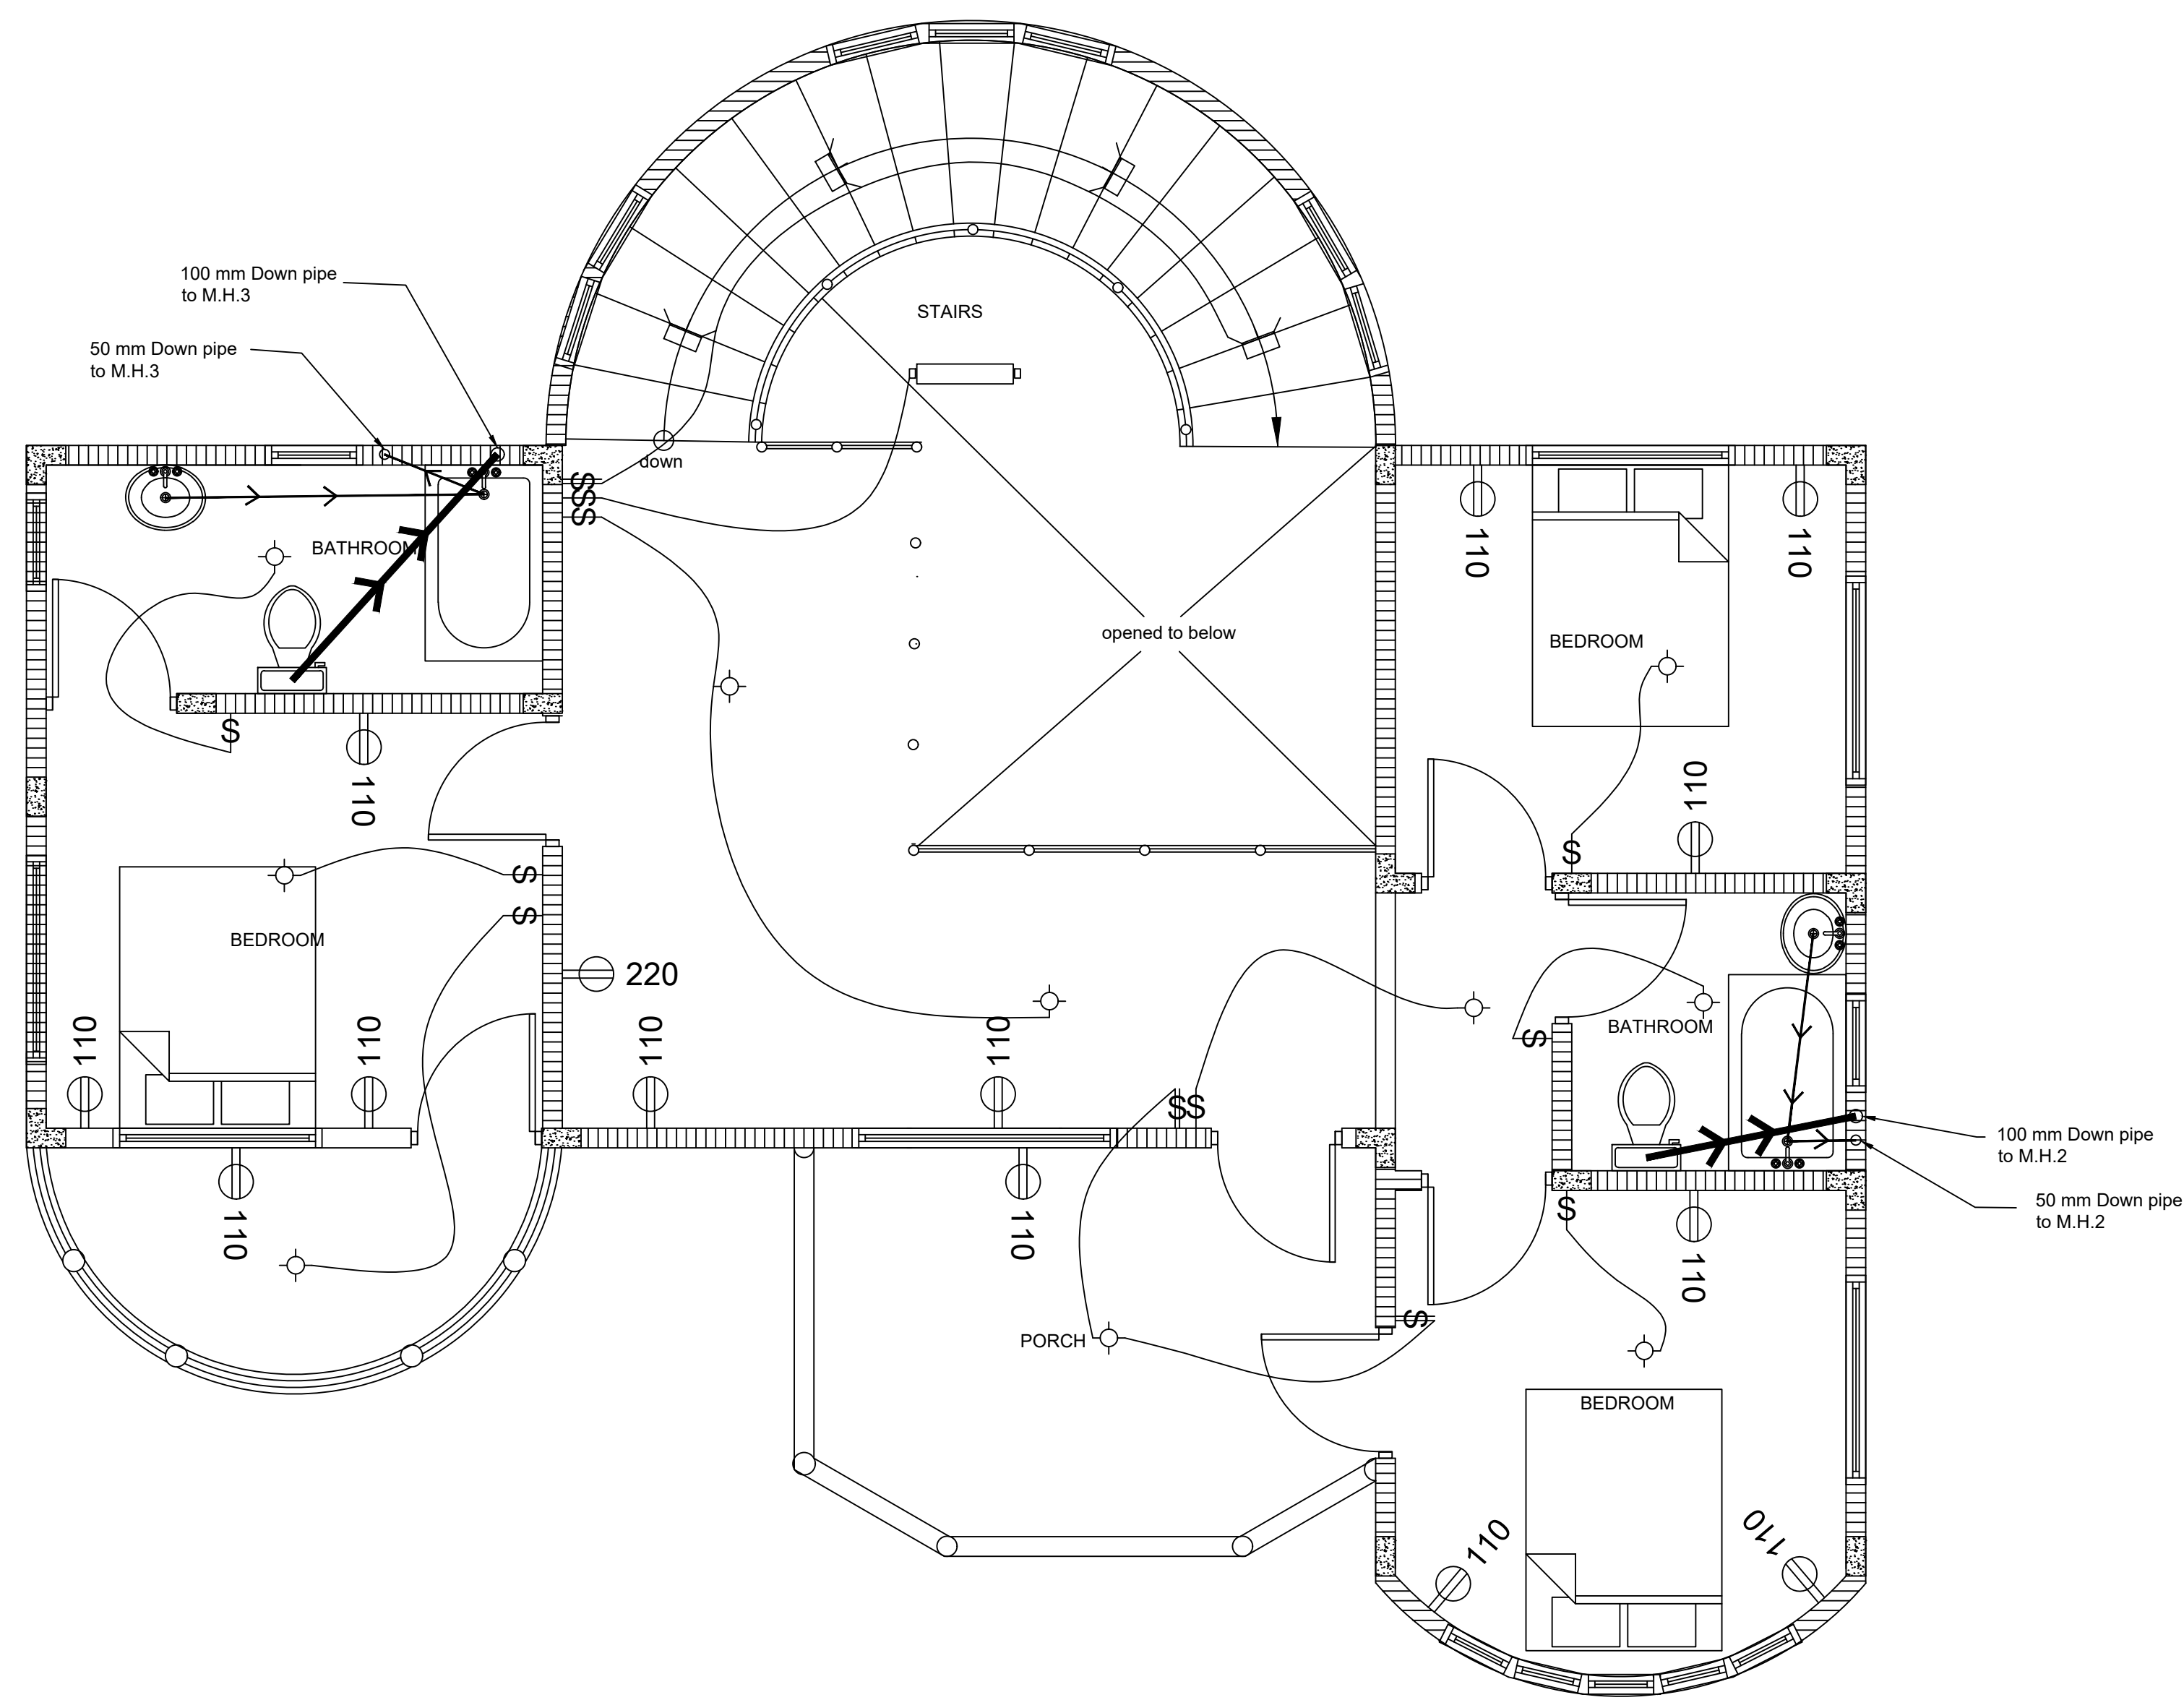

Electrical &
Drainage Plan
Scale: 1:40

Notes

Do not scale from drawing

Do not make any changes to the design unless instructed by the Architect

All dimensions must be checked before and during the construction and only discrepancies found must be reported immediately to the architect

Revisions:

Stamped:

Client: Kayla Thorpe

Projects:

Drawing
Electrical &
Drainage Plan

Plot Scale:	Design: Javier Earle	Job no: 01	Sheet no: A:07
Date: 30/03/18	Drawn: Javier Earle	Scale: 1:40	