



**GROUND FLOOR
PLAN-1**

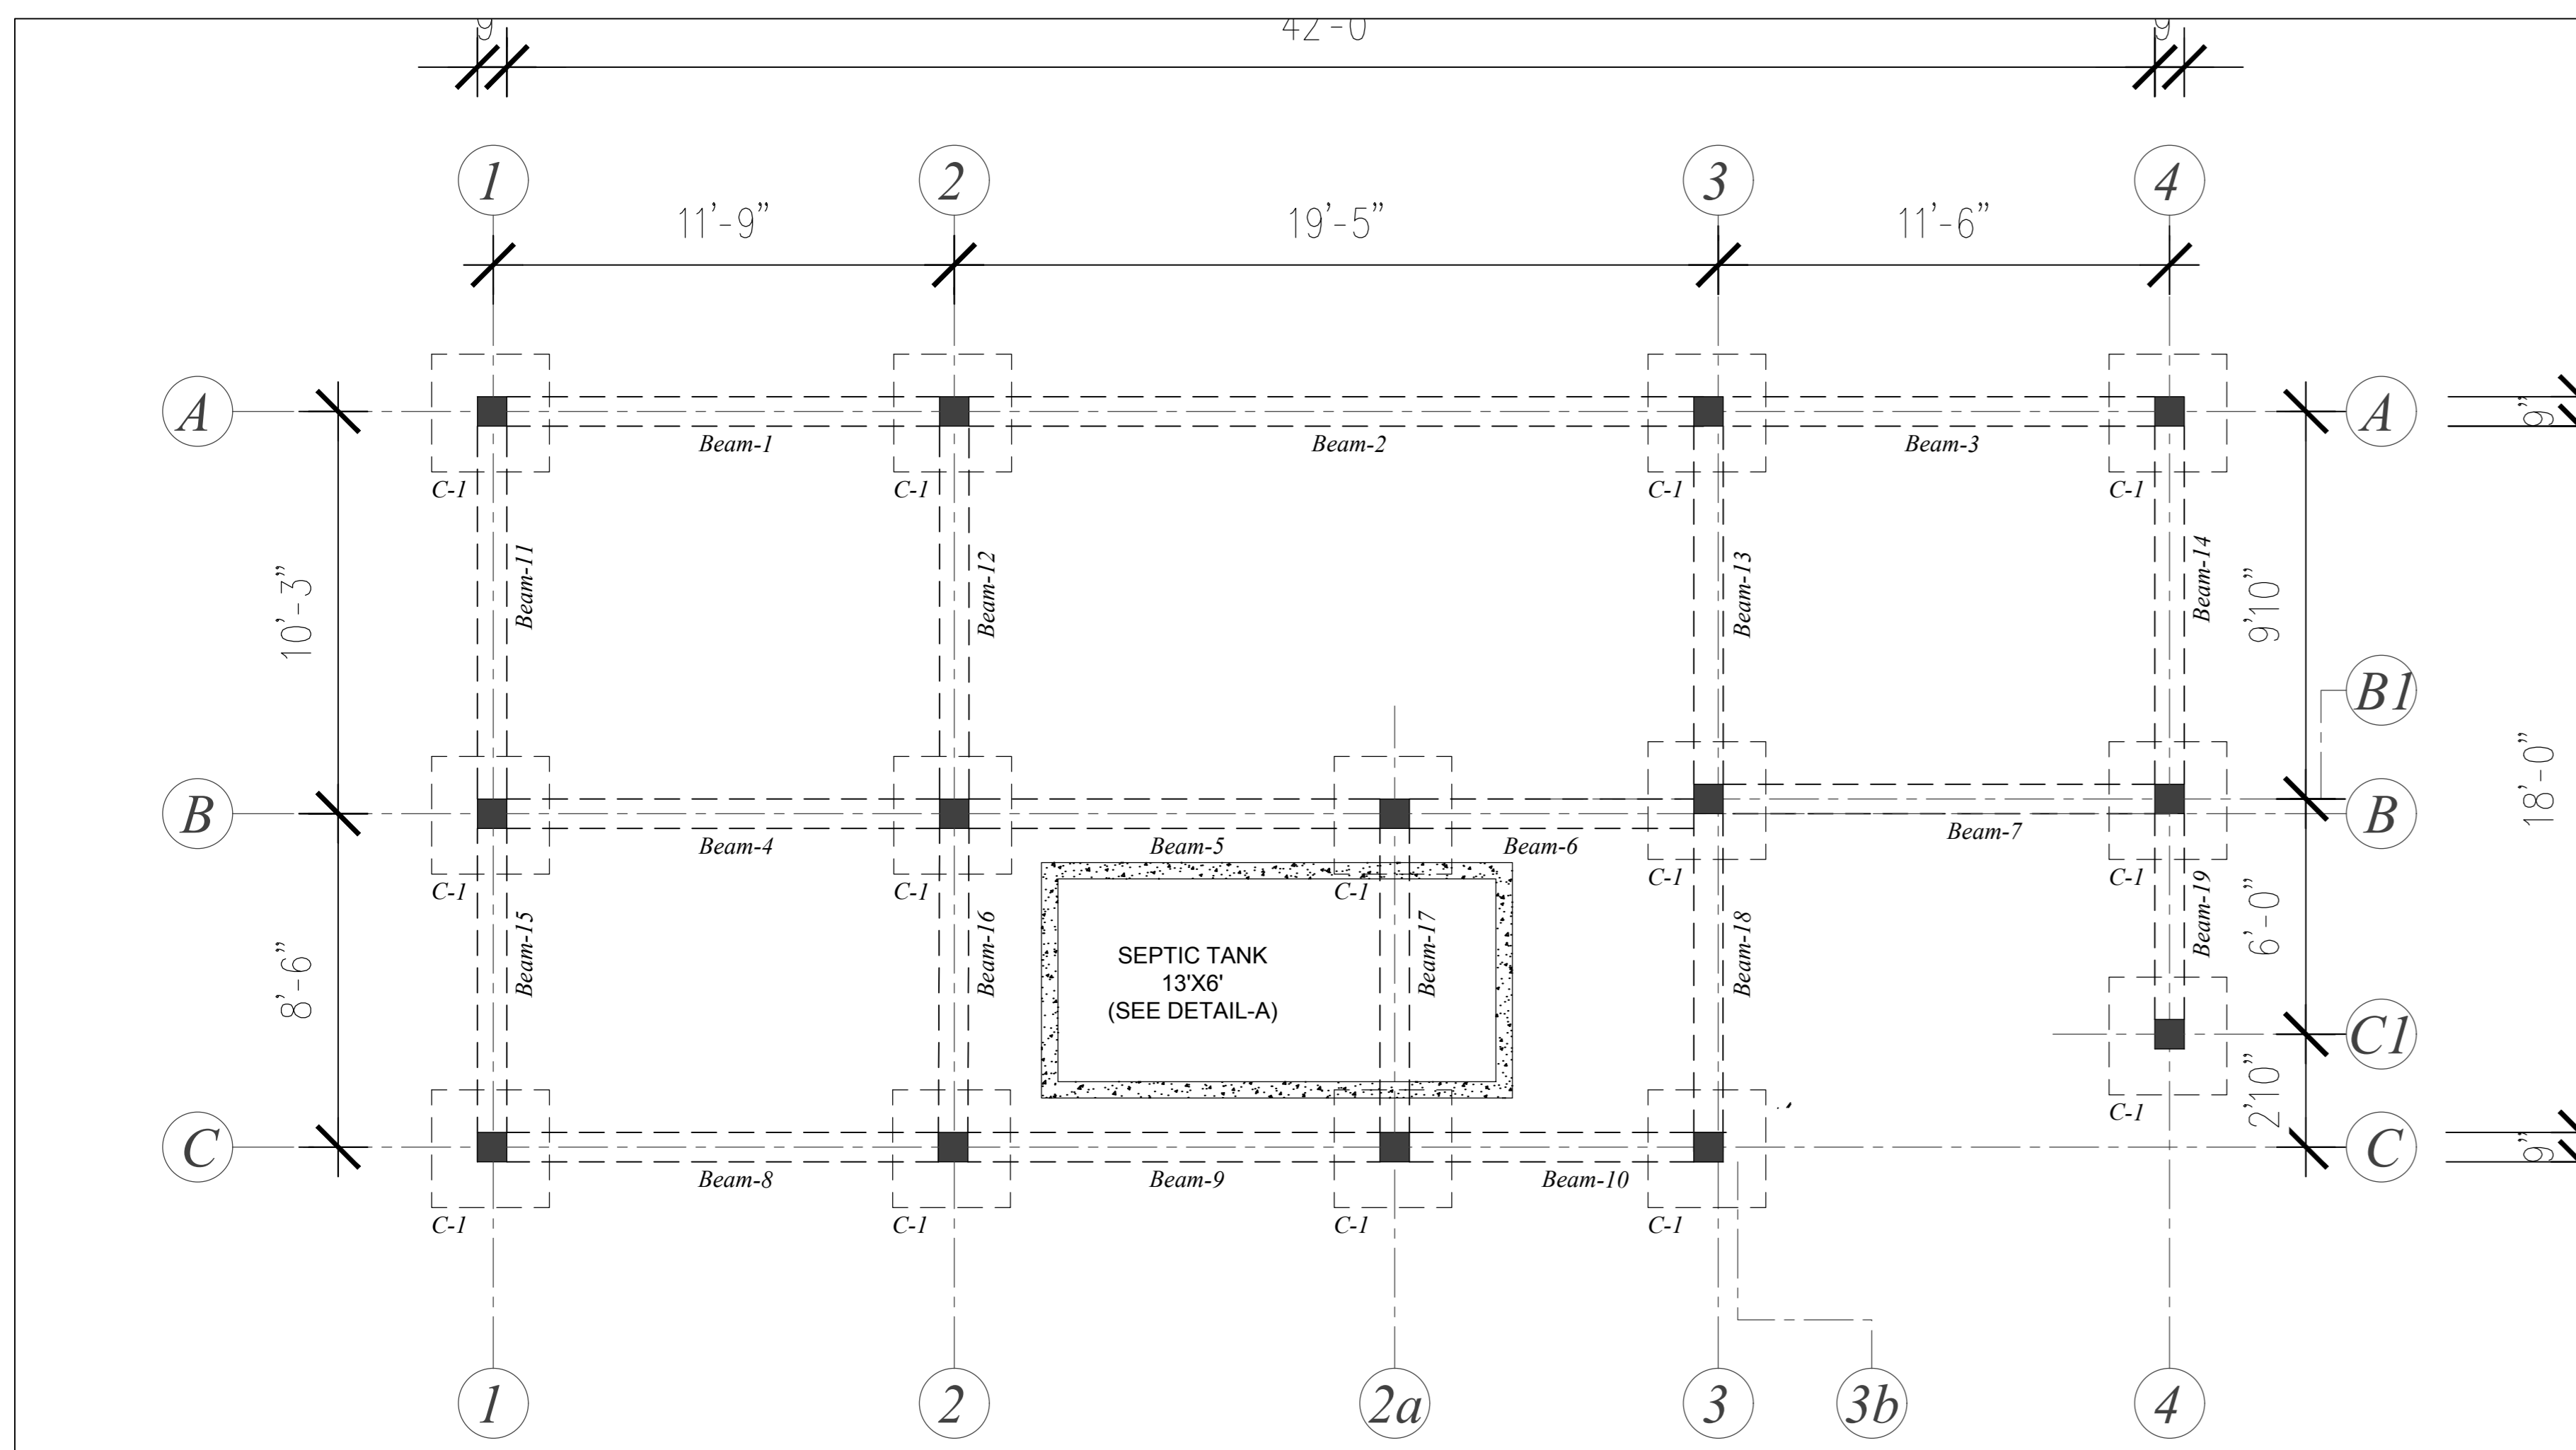

**BEAM & COLUMN
PLAN**

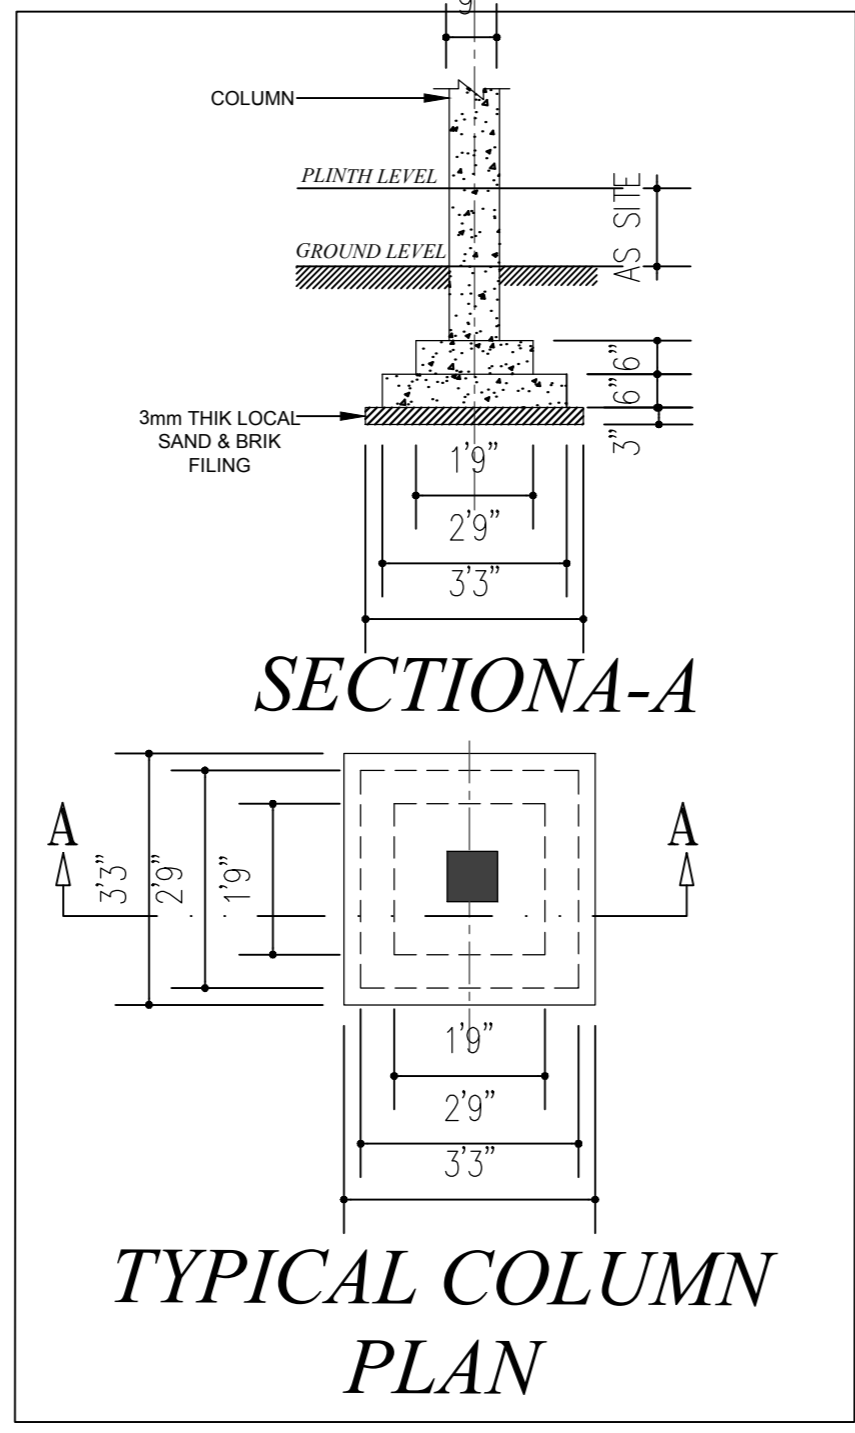

DOOR, WINDOW & VENTILATION SCHEDULE

SR.NO.	NAME	HEIGHT	WIDTH
1	D	7 feet	3 feet
2	D1	7 feet	1 feet 6 inch
3	D2	7 feet	2 feet
4	D3	7 feet	3 feet 6 inch
5	W	4 feet	5 feet
6	W1	4 feet	4 feet
7	W2	4 feet	3 feet
8	V	1 feet 6 inch	2 feet
9	V	1 feet 6 inch	2 feet
10	V2	1 feet 6 inch	1 feet 6 inch

BEAM SCHEDULE




SR.NO.	NAME	HEIGHT	WIDTH	LENGTH
1	Beam-1	9 inch	9 inch	As site
2	Beam-2	9 inch	9 inch	As site
3	Beam-3	9 inch	9 inch	As site
4	Beam-4	9 inch	9 inch	As site
5	Beam-5	9 inch	9 inch	As site
6	Beam-6	9 inch	9 inch	As site
7	Beam-7	9 inch	9 inch	As site
8	Beam-8	9 inch	9 inch	As site
9	Beam-9	9 inch	9 inch	As site
10	Beam-10	9 inch	9 inch	As site
11	Beam-11	9 inch	9 inch	As site
12	Beam-12	9 inch	9 inch	As site
13	Beam-13	9 inch	9 inch	As site
14	Beam-14	9 inch	9 inch	As site
15	Beam-15	9 inch	9 inch	As site
16	Beam-16	9 inch	9 inch	As site
17	Beam-17	9 inch	9 inch	As site
18	Beam-18	9 inch	9 inch	As site

COLUMN SCHEDULE


SR.NO.	1
COLUMN NAME	C1
COLUMN SIZE	9"X9"
COLUMN DIAGRAM	

COLUMN R/F SCHEDULE

SR.NO.	1
TOP OF FOUNDATION TO TERRACE FLOOR LVL	a = 4 - 12mmØ b = 4 - 8mmØ
COLUMN SIZE	9"X9"
REINFORCEMENT ARRANGEMENT	
TIES TYPE	

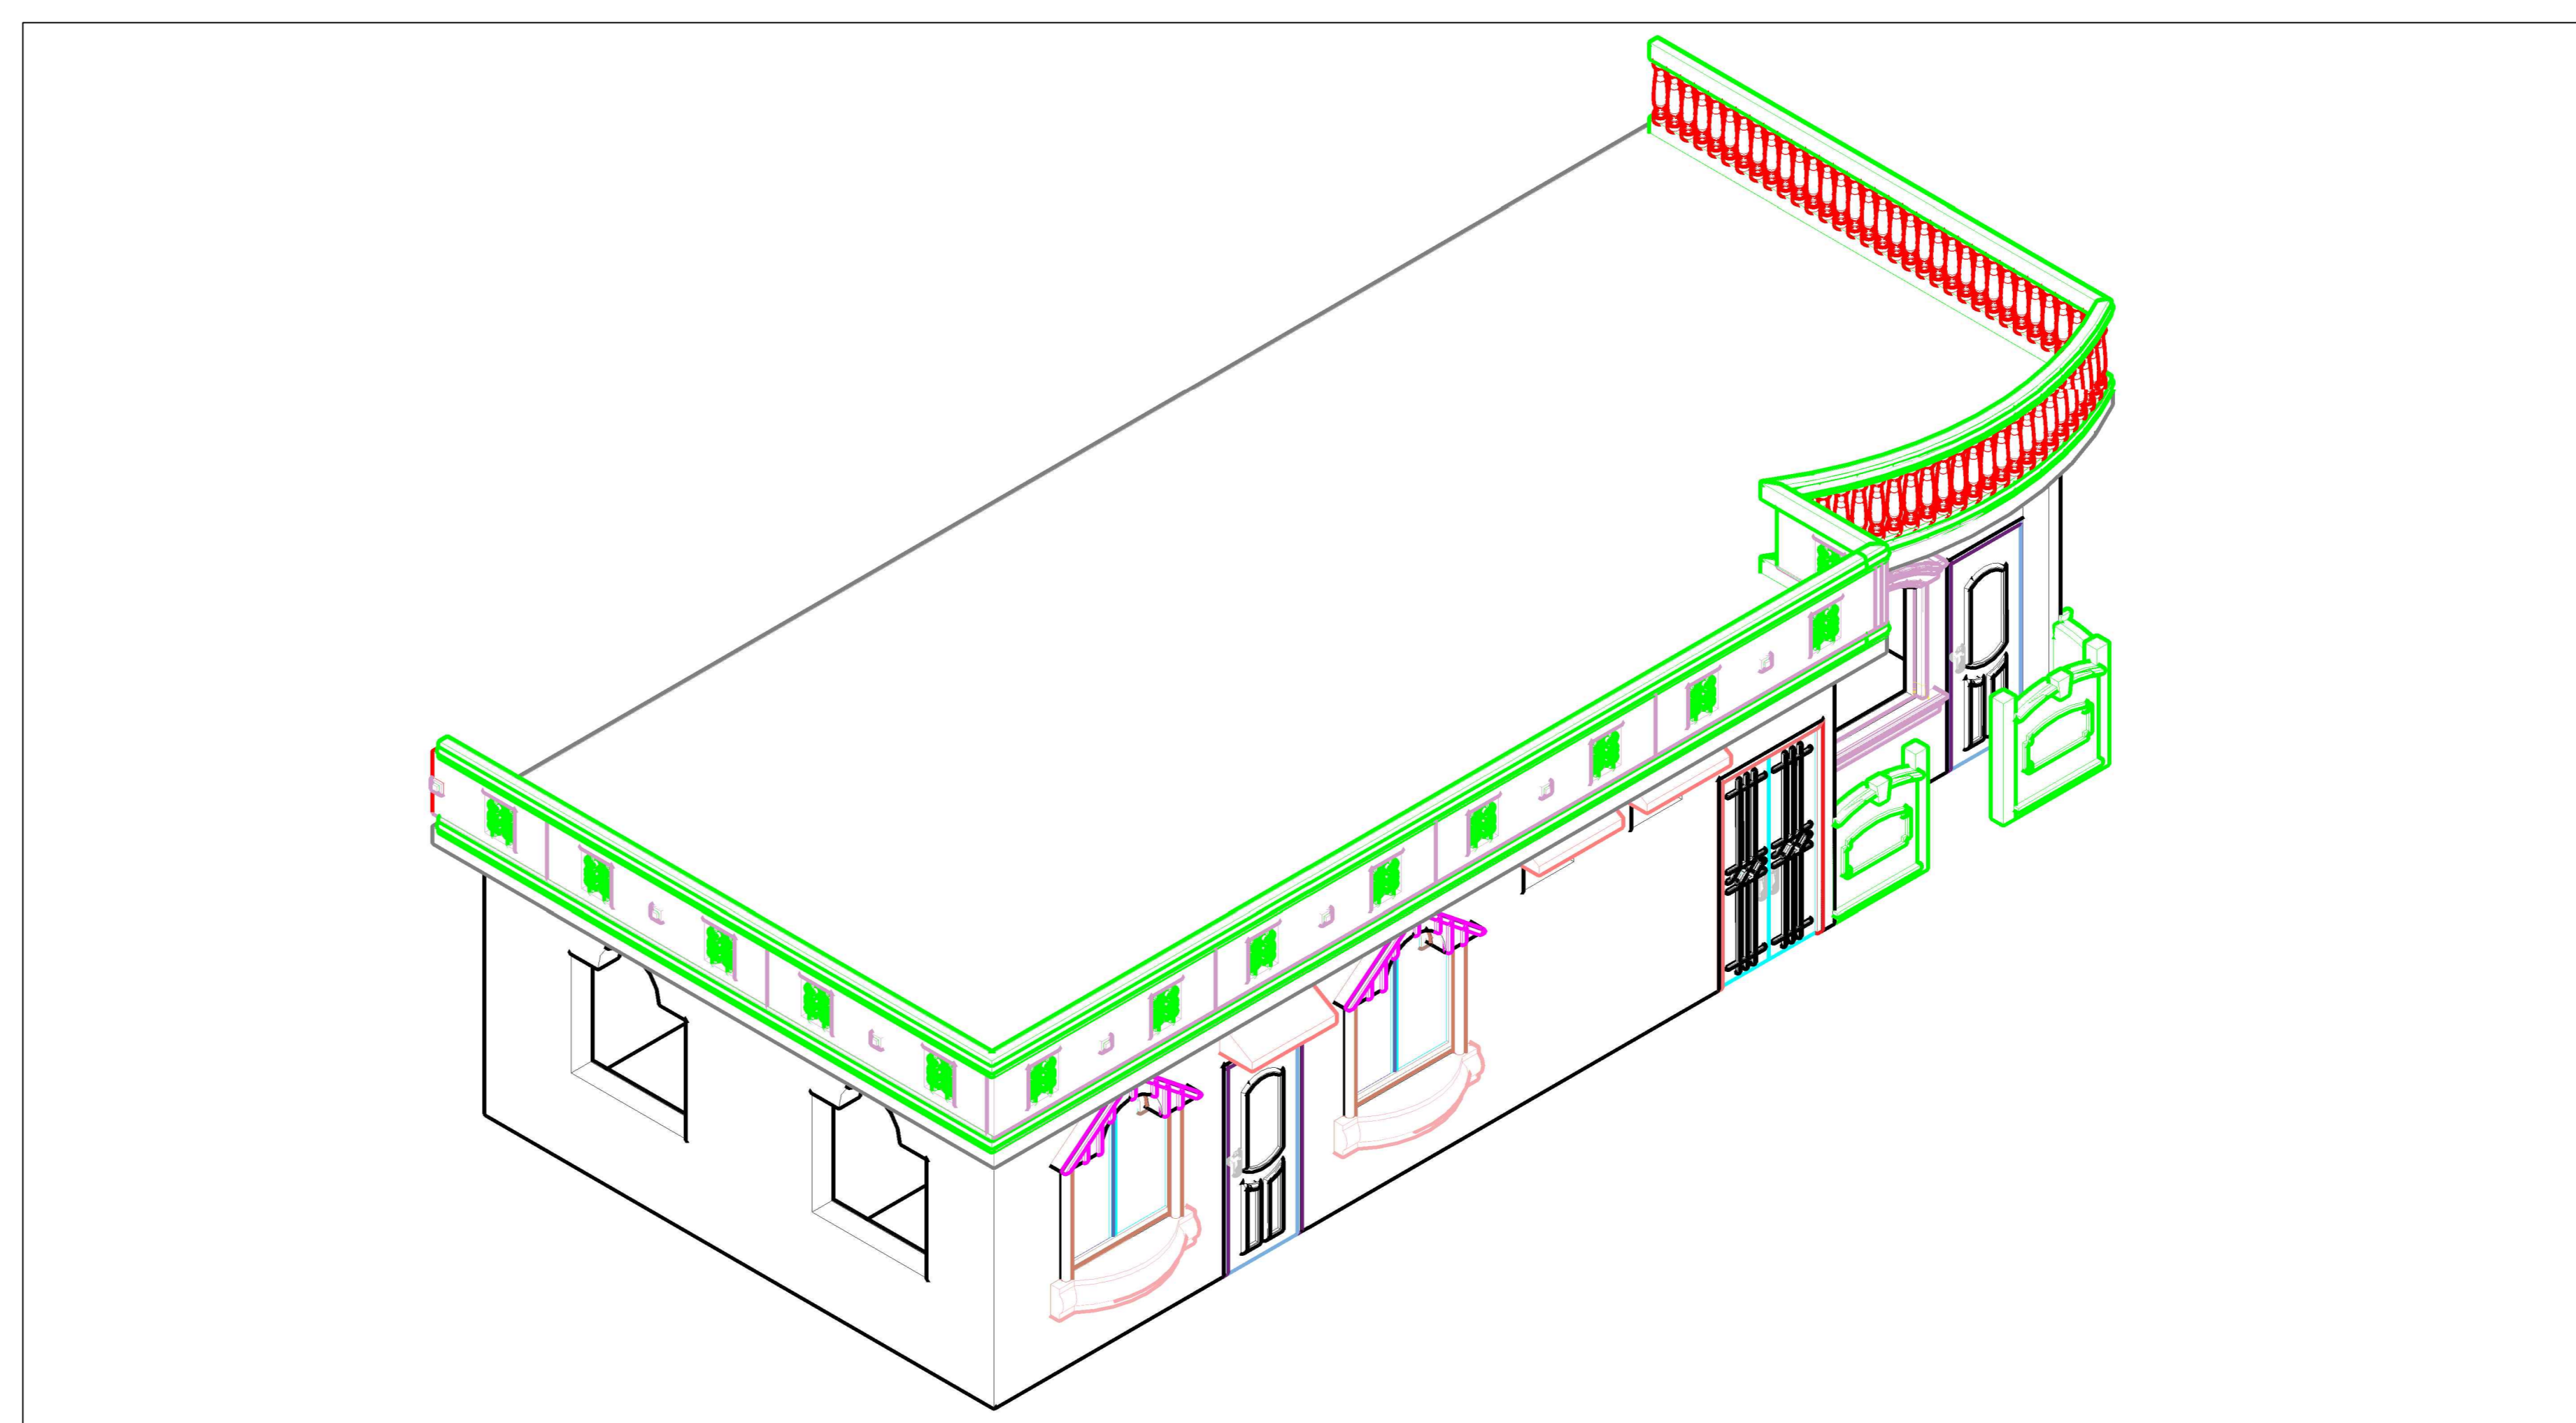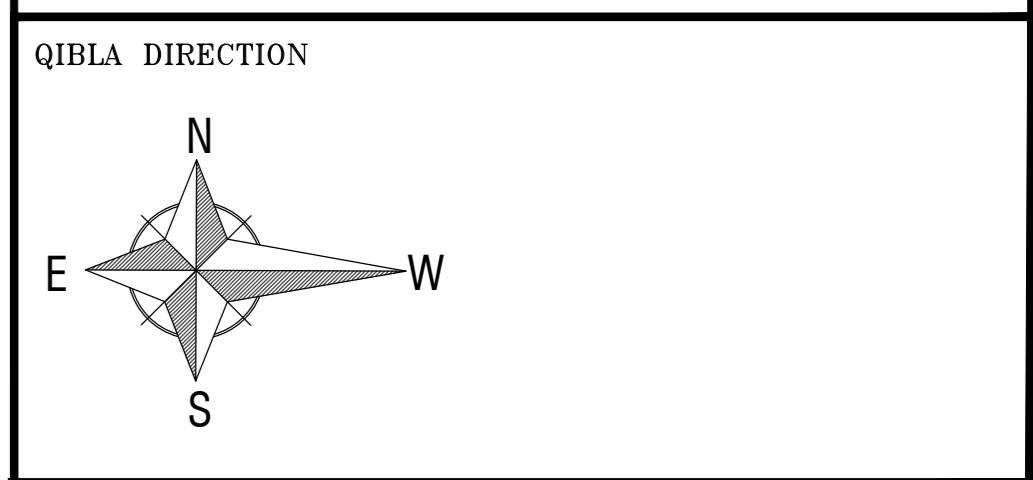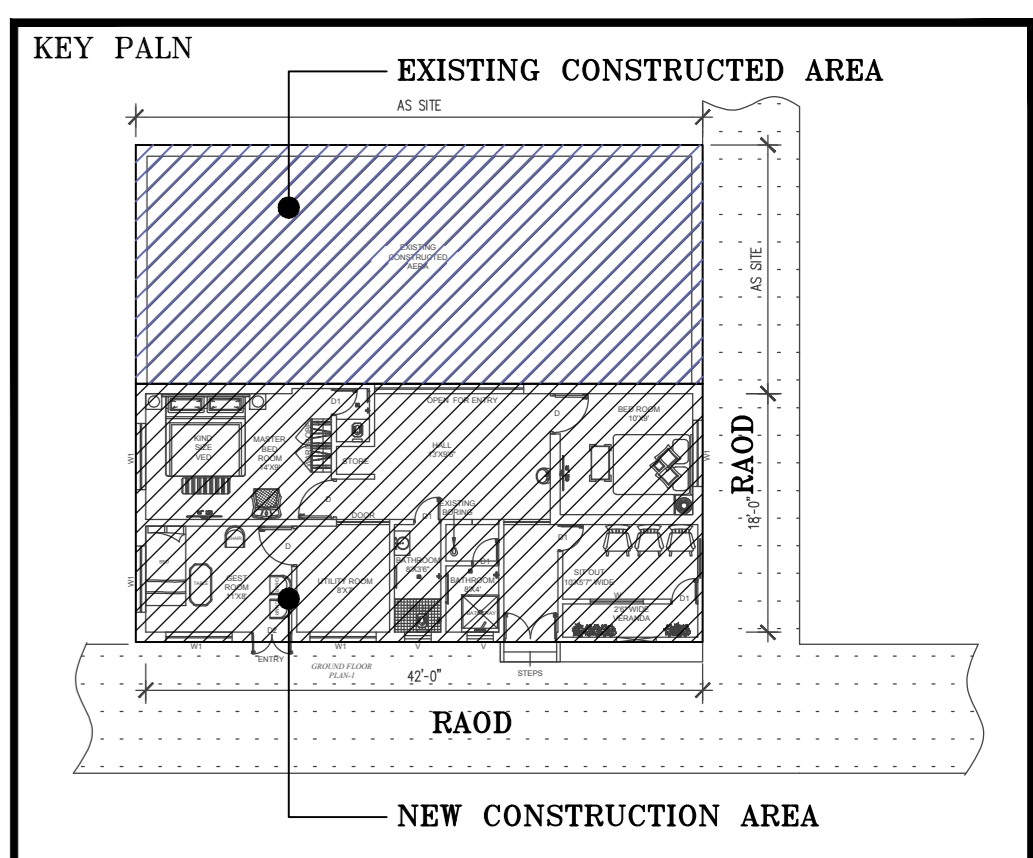

3D VIEW DETAIL

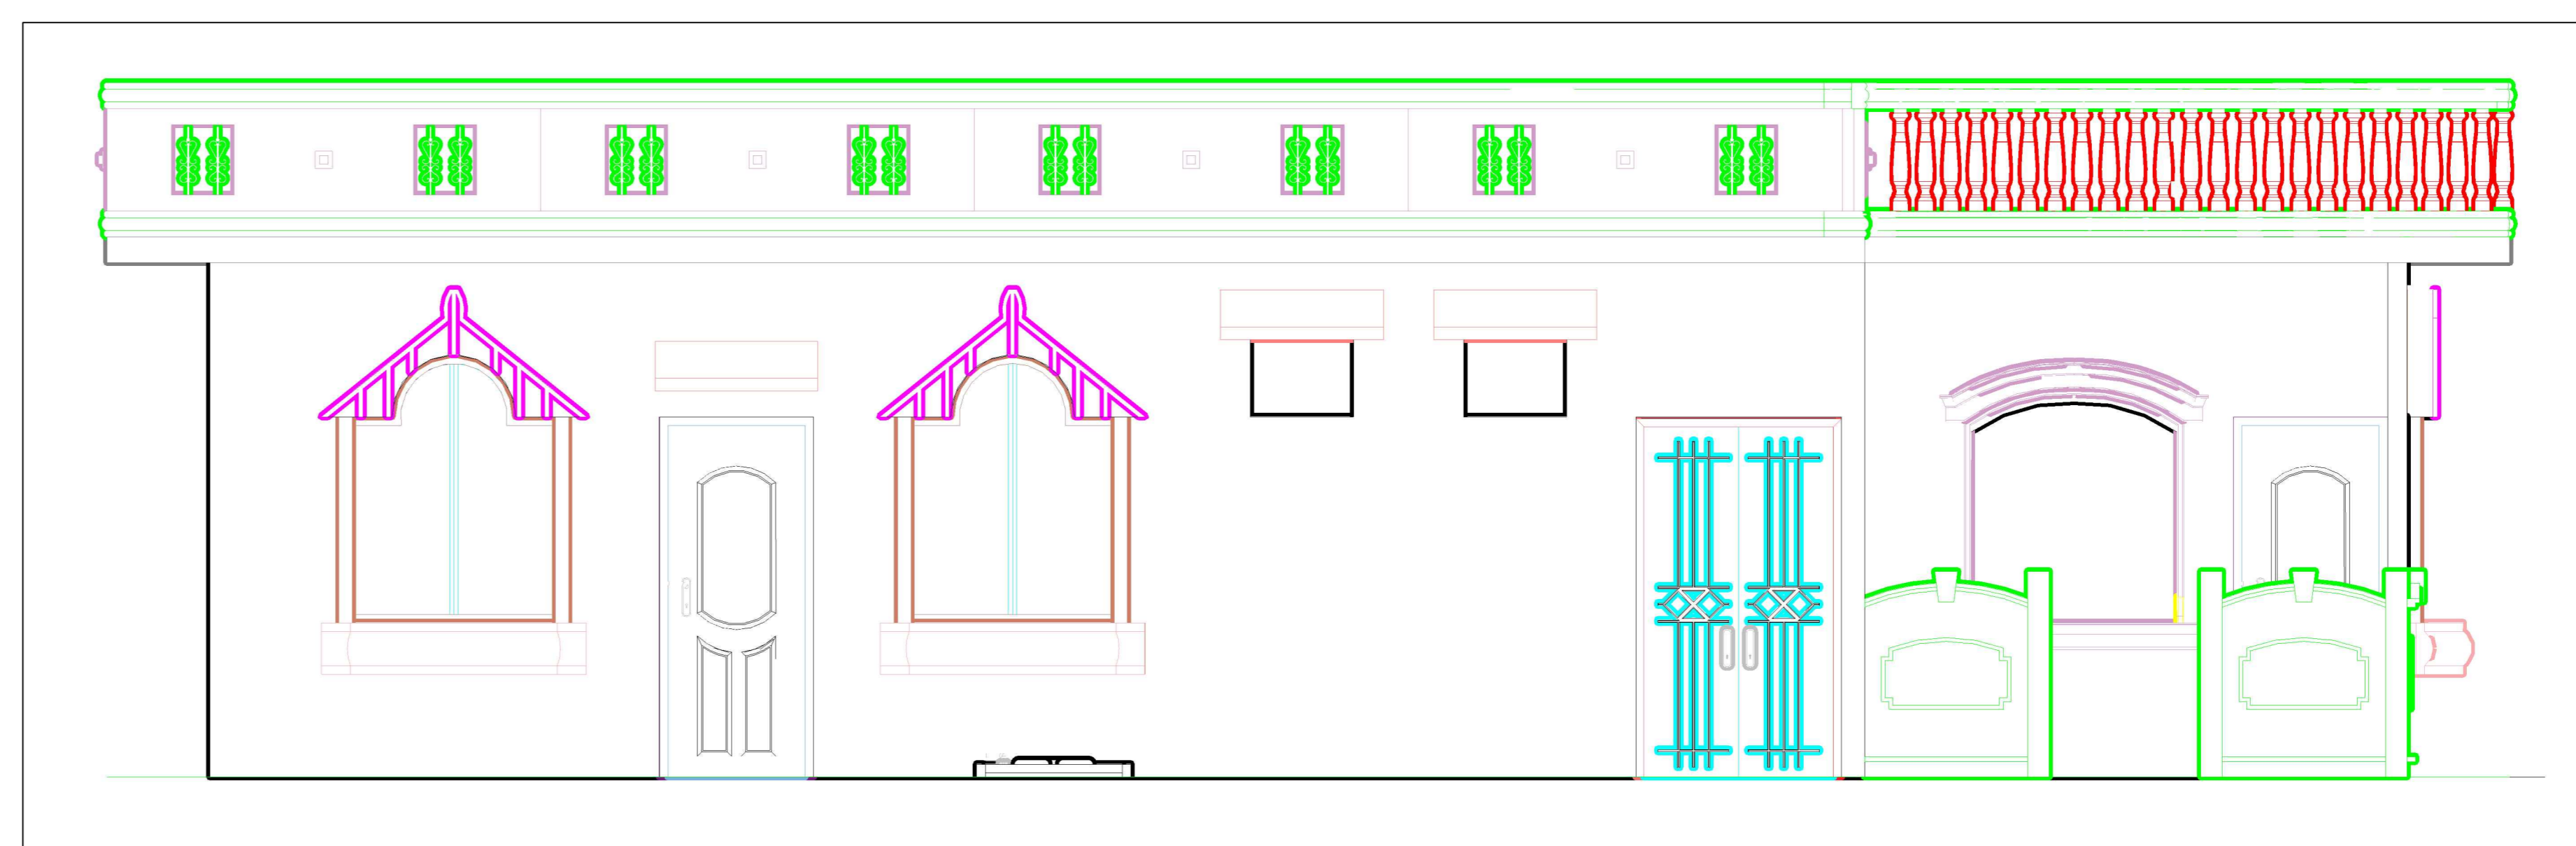

**FRONT ELEVATION
DEATIL**

BUILDING		2 BHK RESIDENCIAL HOME GROUND FLORR	
DRAWING TITLE		GROUND FLOOR PALN	
DATE	SCALE	NTS	
25/02/2018	0.00 1.00 2.00 4.00 m		
DRAWN BY:	CHECKED BY:	APPROVED BY:	
FAROOQUE ANSARI	N/A	N/A	
JOB NO. BUILDING NO.	DRAWING NO.	REVISION:	
--	SOW-001	0	