

TYPE	PIN LIGHT COOL WHITE	DOWN LIGHT COOL WHITE	CEILING FAN	
BC1	9VA	9VA	50VA	TOTAL
QTY	10	9	1	20
	90VA	81VA	50VA	221VA


**E**  
2-11 SCALE 1:50MTS

**LIGHTING LOAD**


SYMBOL	DESCRIPTION
	SMALL APPLIANCE, 2 GANG
	WEATHERPROOF LAUNDRY OUTLET
	ELECTRIC RANGE
	AIR CONDITIONING OUTLET
	WATER HEATER PER SHOWER
	WEATHERPROOF OUTLET
	PIN LIGHT (WARM WHITE)
	DOWN LIGHT(COOL WHITE)
	1 GANG SWITCH 1 POLE
	2 GANG SWITCH 2 POLE
	3 GANG SWITCH 2 POLE
	3 WAY SWITCH 1 POLE
	CEILING FAN FOUR BLADE
	BRANCH CIRCUIT HOMERUN
	PANEL BOARD
	ENCLOSE CIRCUIT BREAKER
	SERVICE METER

**E**  
3-11 SCALE 1:50MTS

**LEGENDS & SYMBOLS**

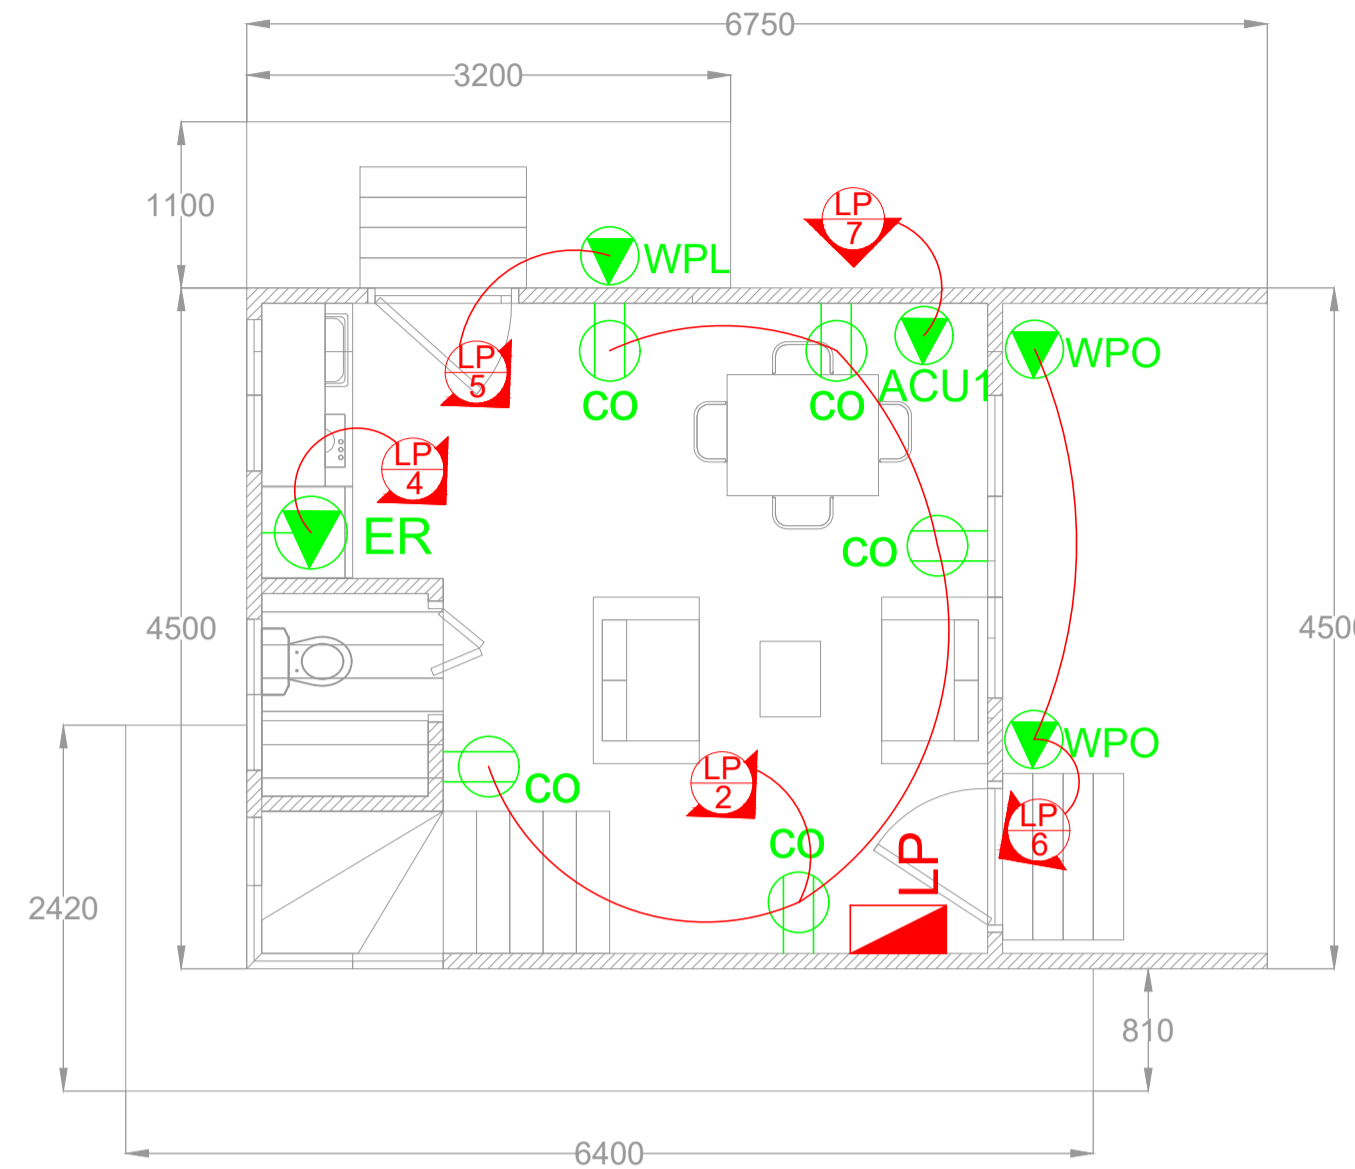


GROUND FLOOR

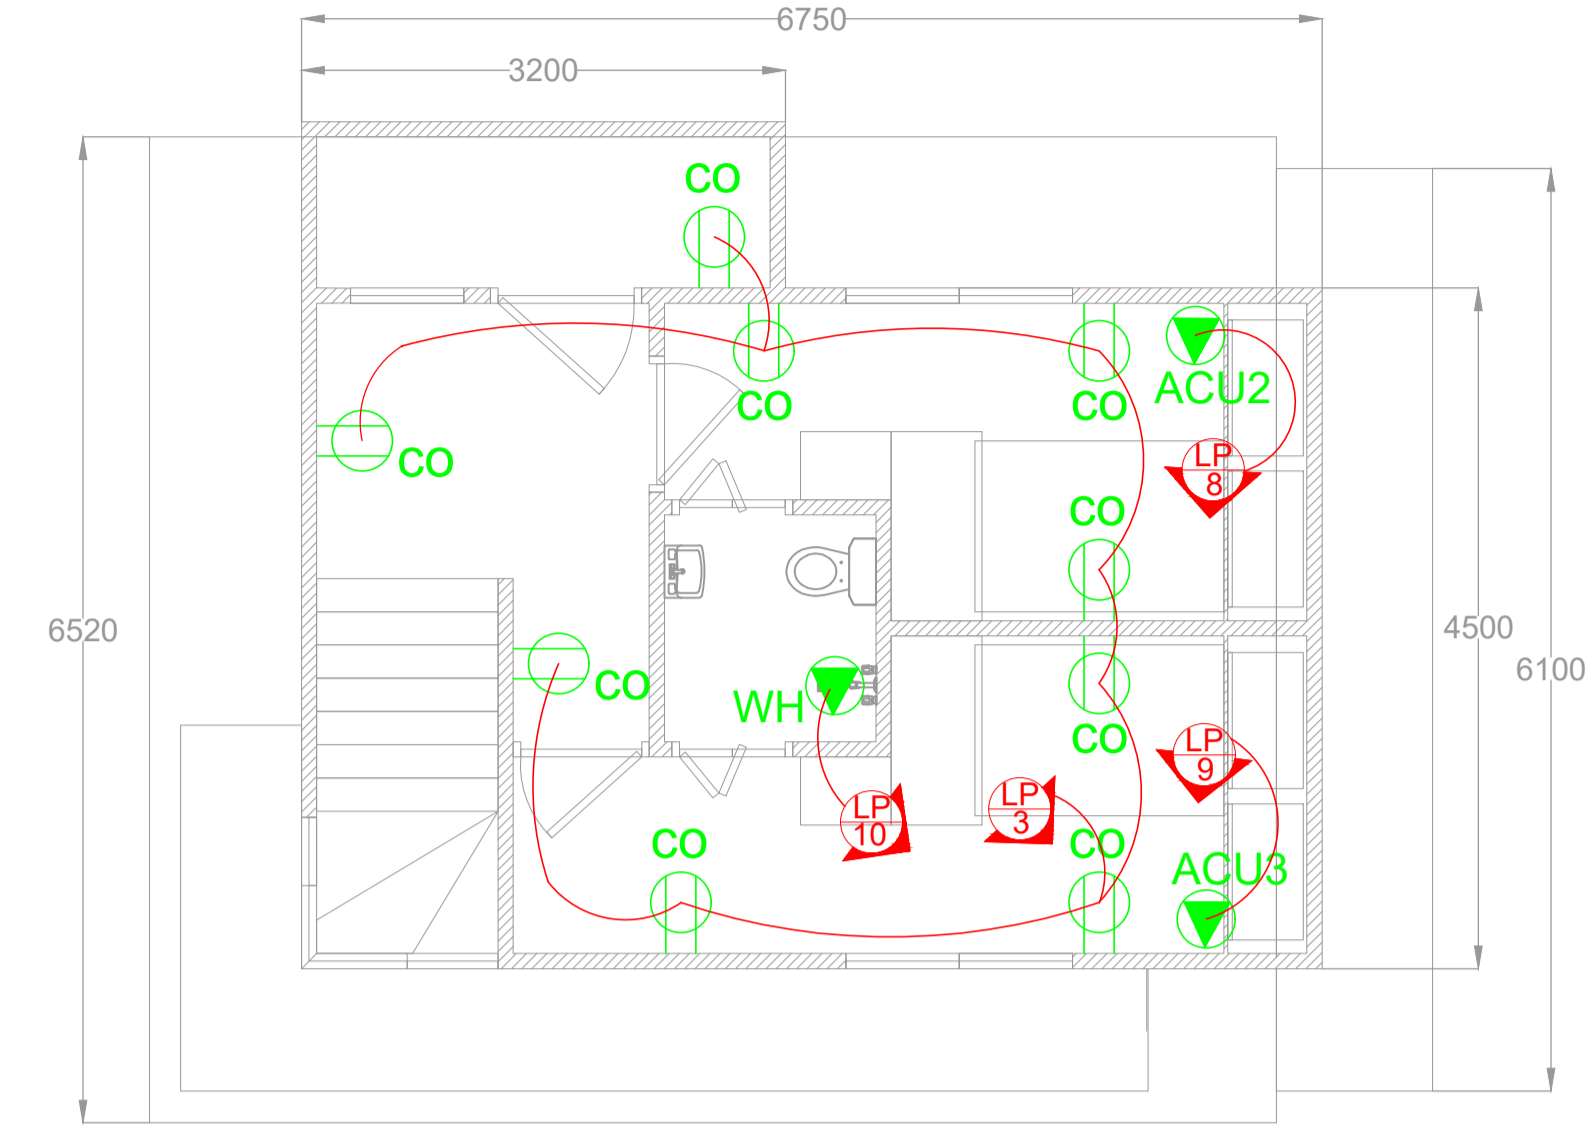


SECOND FLOOR

**E**  
4-11 SCALE 1:50MTS

**POWER LAYOUT**

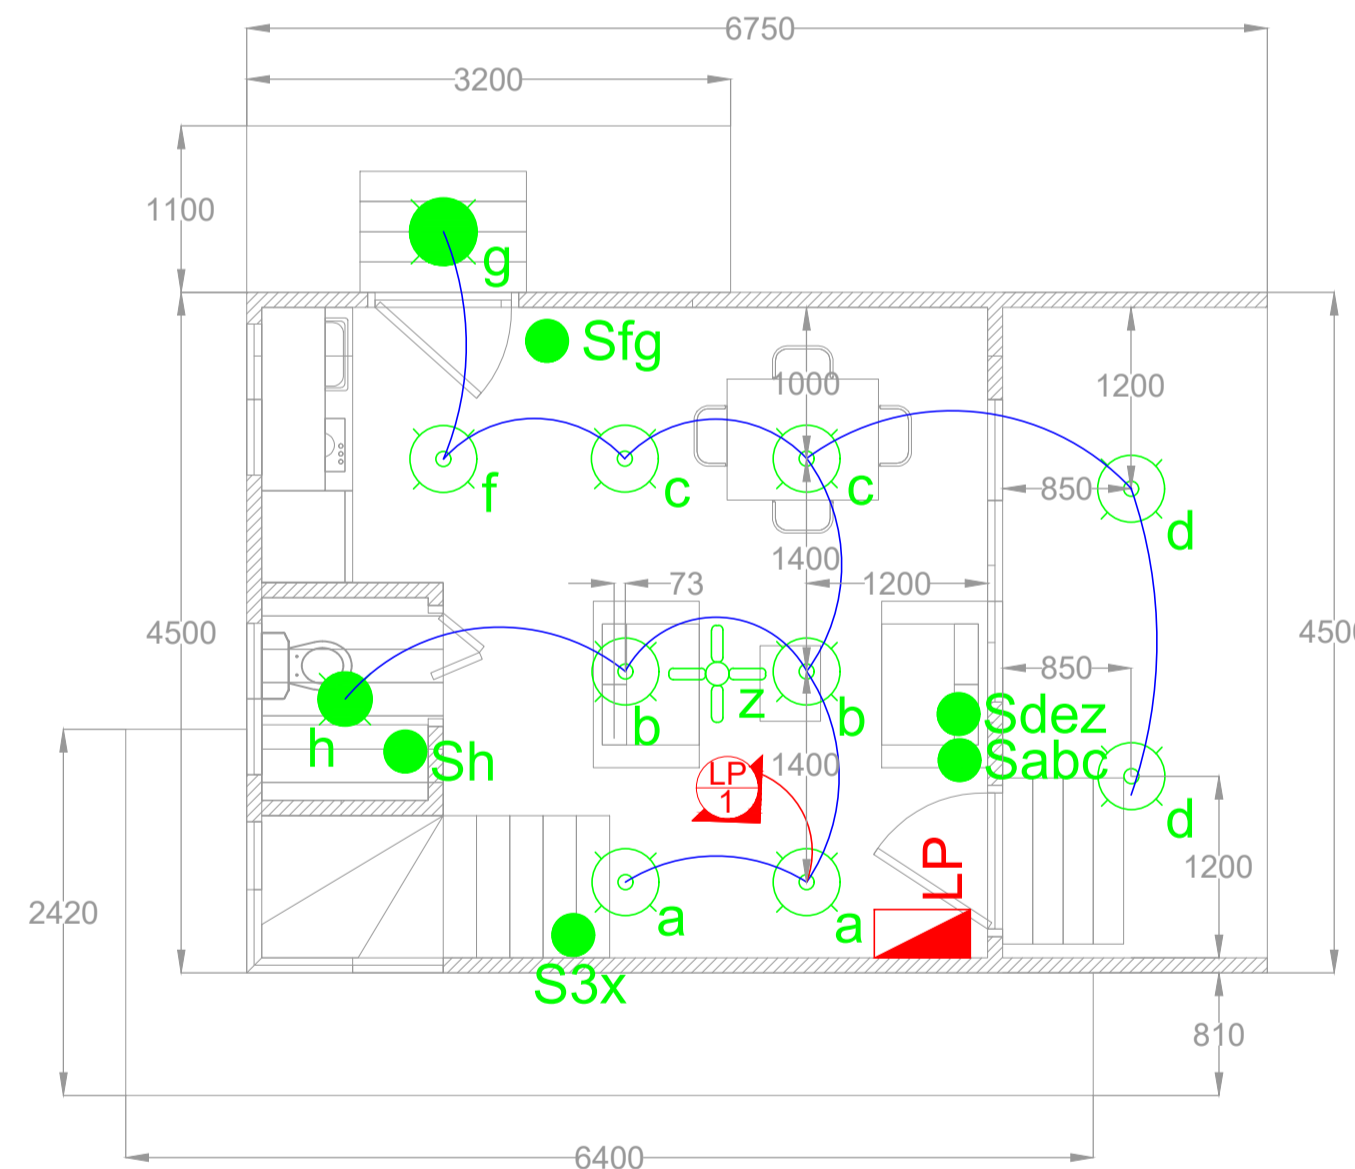

GROUND FLOOR

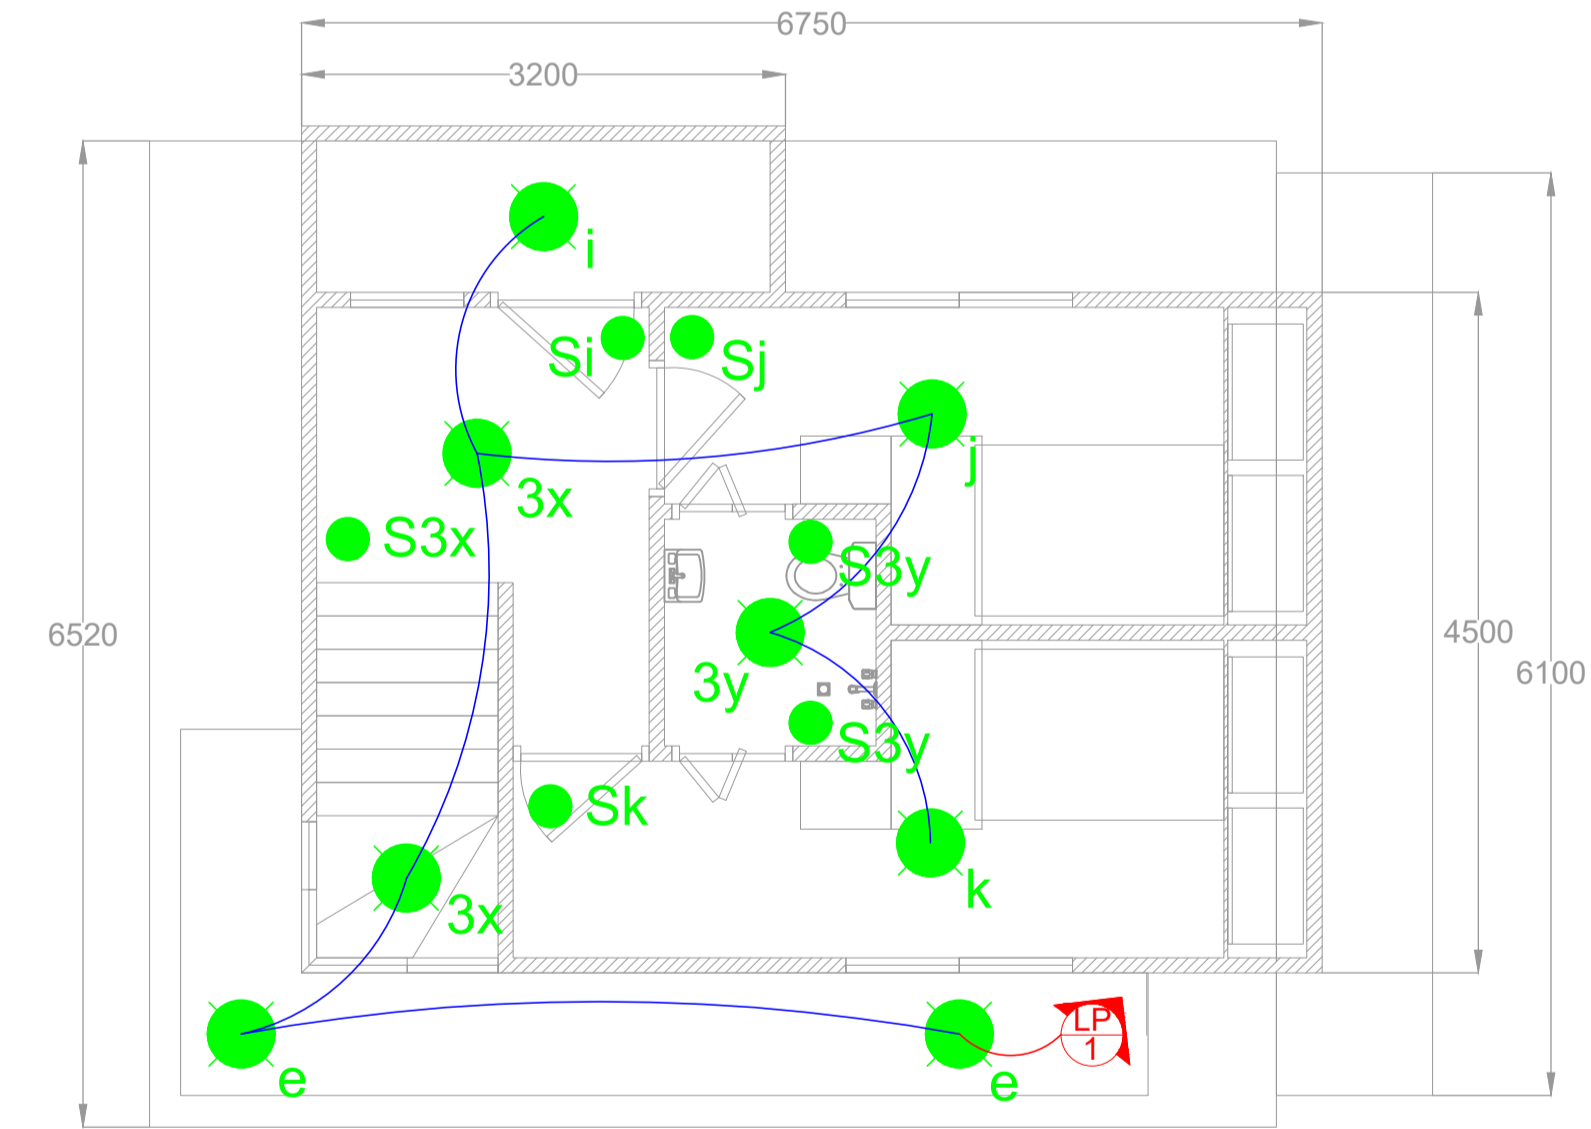

SECOND FLOOR

**E**  
5-11 SCALE 1:50MTS

**LIGHTING LAYOUT**

DESIGNER:	PEE:	PROJECT TITLE:	APPROVED BY:	REVISIONS	SHEET CONTENTS:	SHEET NO.
		PROPOSED 2 STOREY TOWNHOUSE (ELECTRICAL DESIGN LAYOUT)		DRAWN BY:	<b>LEGENDS &amp; SYMBOLS</b> <b>POWER LAYOUT</b> <b>LIGHTING LAYOUT</b> <b>LIGHTING LOAD</b>	
PRC:	VALID:		OWNER:	DATE:		
PTR:	DATE:			REVISION:		
				REV. DATE:		
						PAGE 2 OF 4